


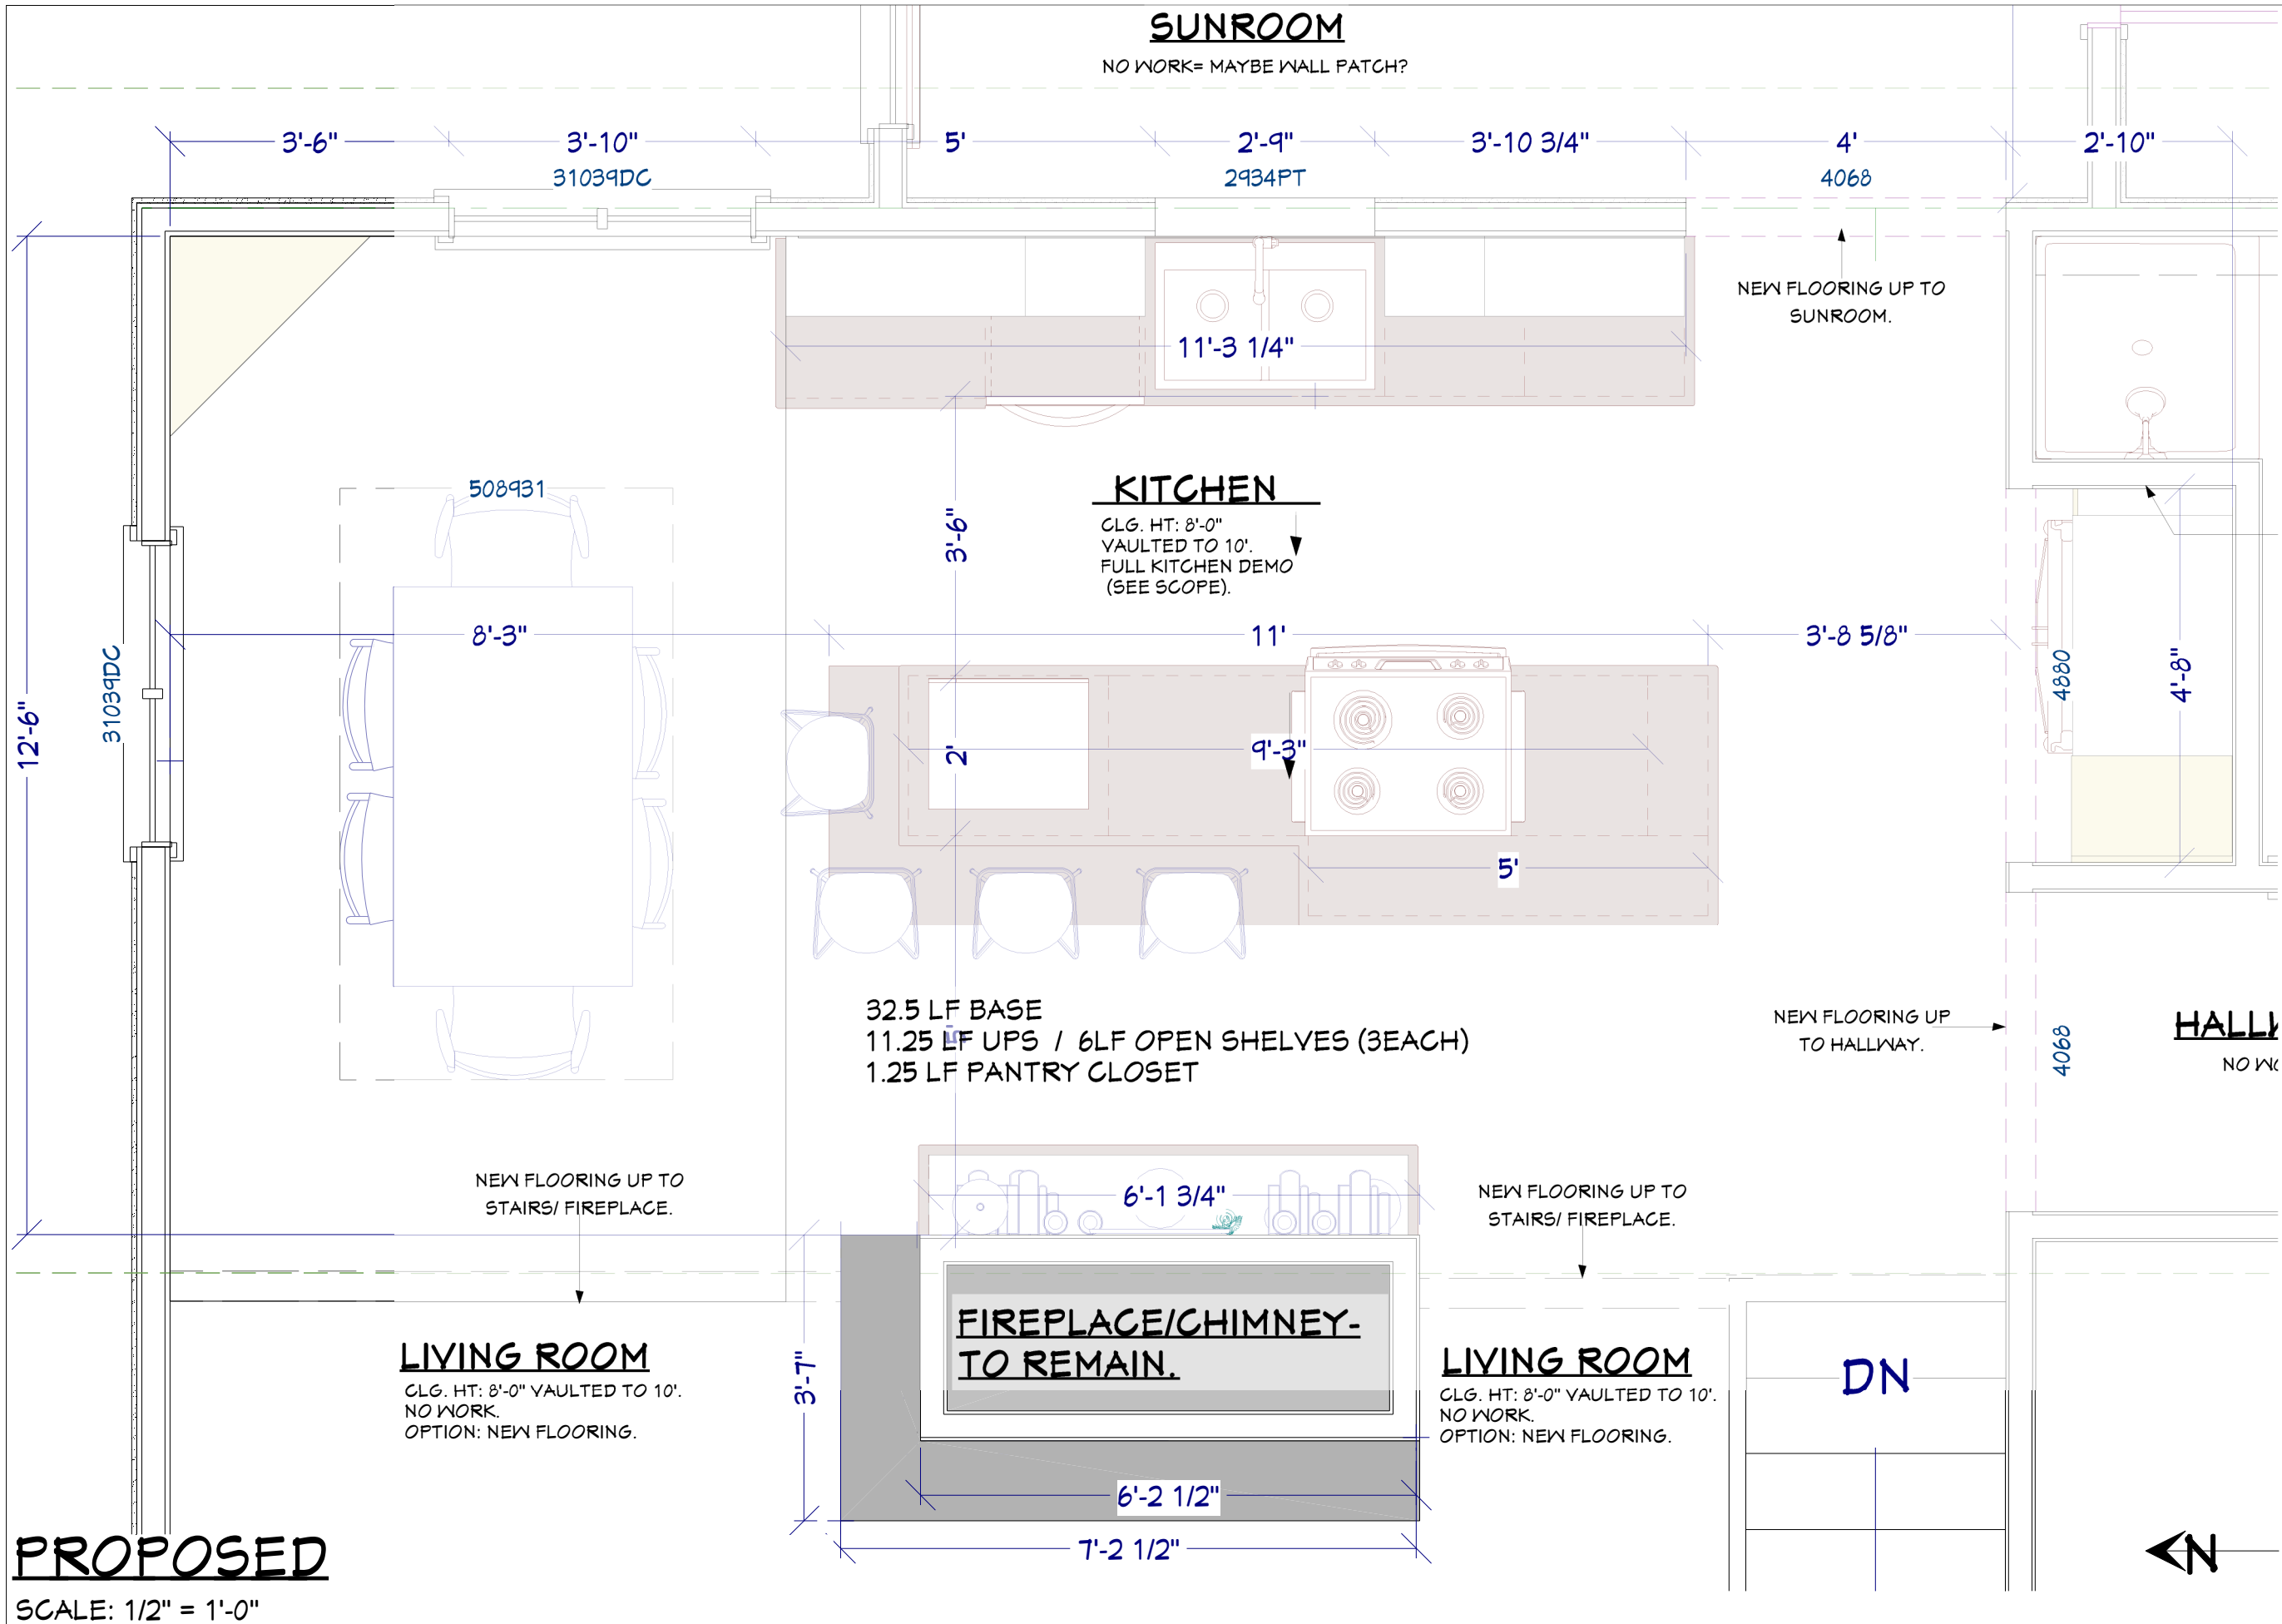

PROPOSED
SCALE: 1/2" = 1'-0"

DATE: 11/9/2018

DRAWN BY: EMILY B.

REVISION DATES:

REV 1: --/--/--


Owner:

CONTRACTOR
LICENSE: MN B005657

Phone: 612-784-8504
Fax: 612-784-8528

Castle
Building & Remodeling
2710 E 33rd St
Minneapolis, Minnesota 55406

PAGE 3

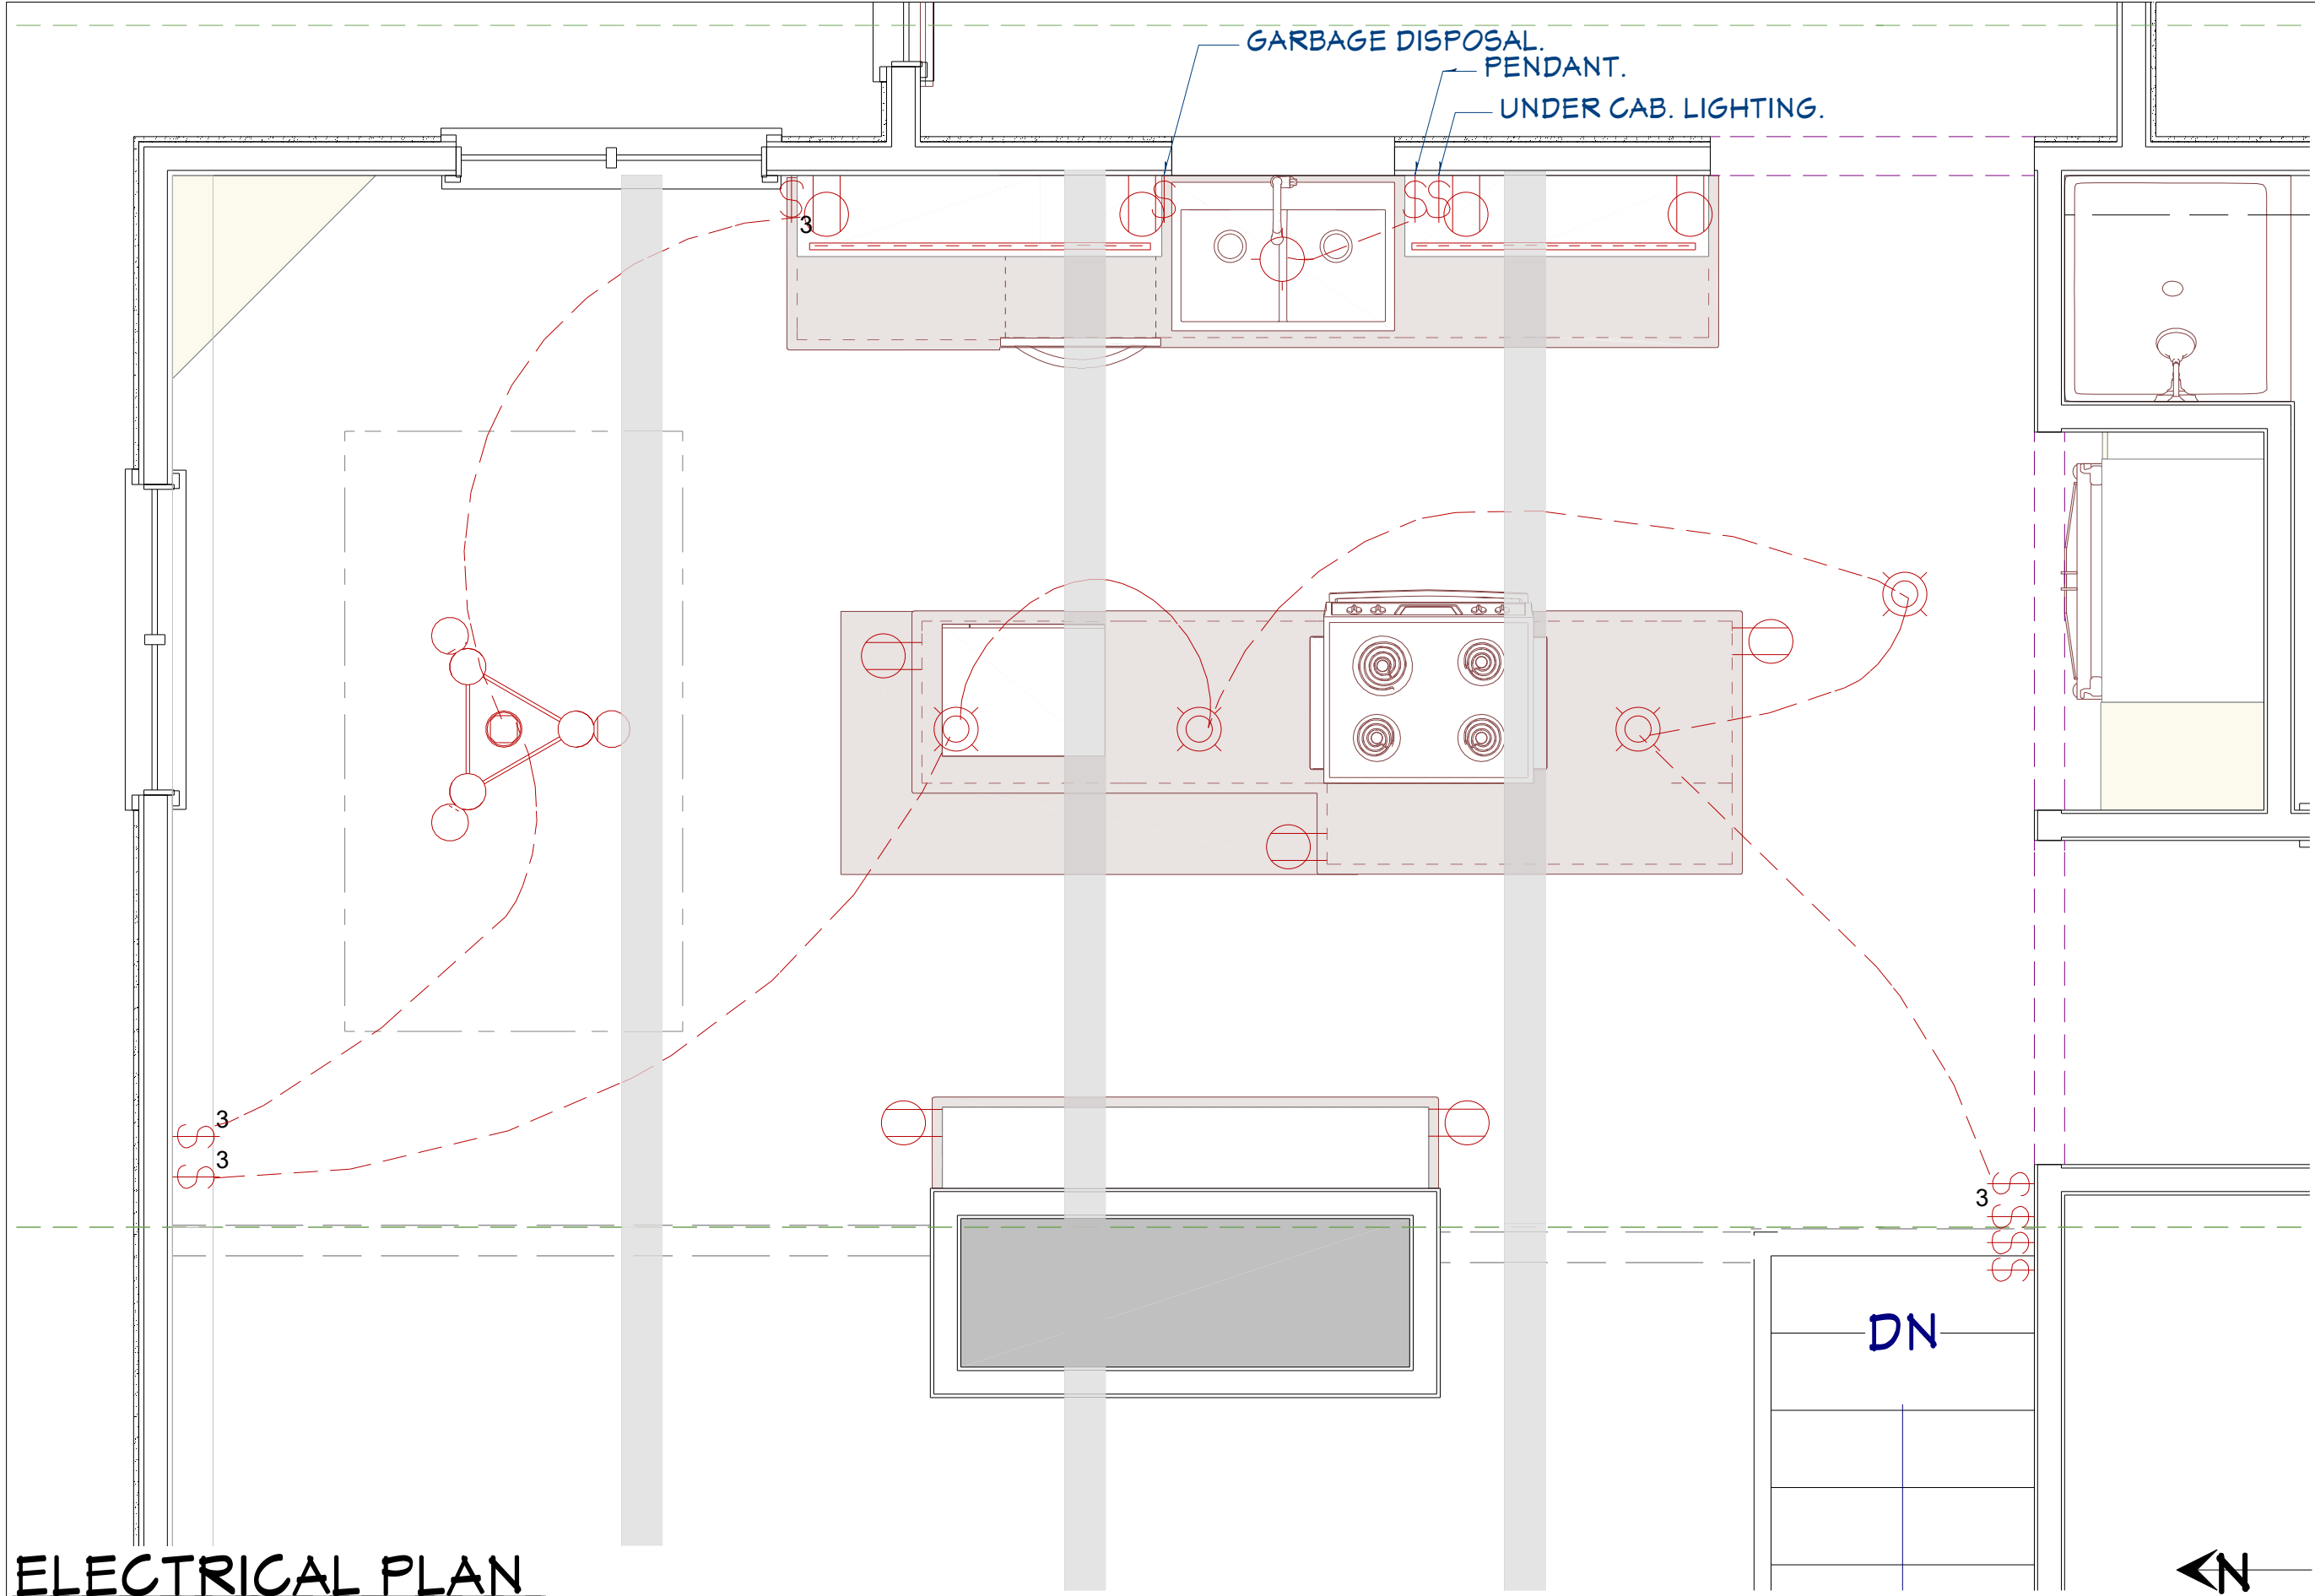

ELECTRICAL PLAN

SCALE: 1/2" = 1'-0"

DATE: 11/9/2018

DRAWN BY: EMILY B.

REVISION DATES:

REV 1: --/--/--

Owner:



CONTRACTOR LICENSE: MN B005657

Phone: 612-784-8504

Fax: 612-784-8528

 **Castle**
Building & Remodeling
2710 E 33rd St
Minneapolis, Minnesota 55406

PAGE 4

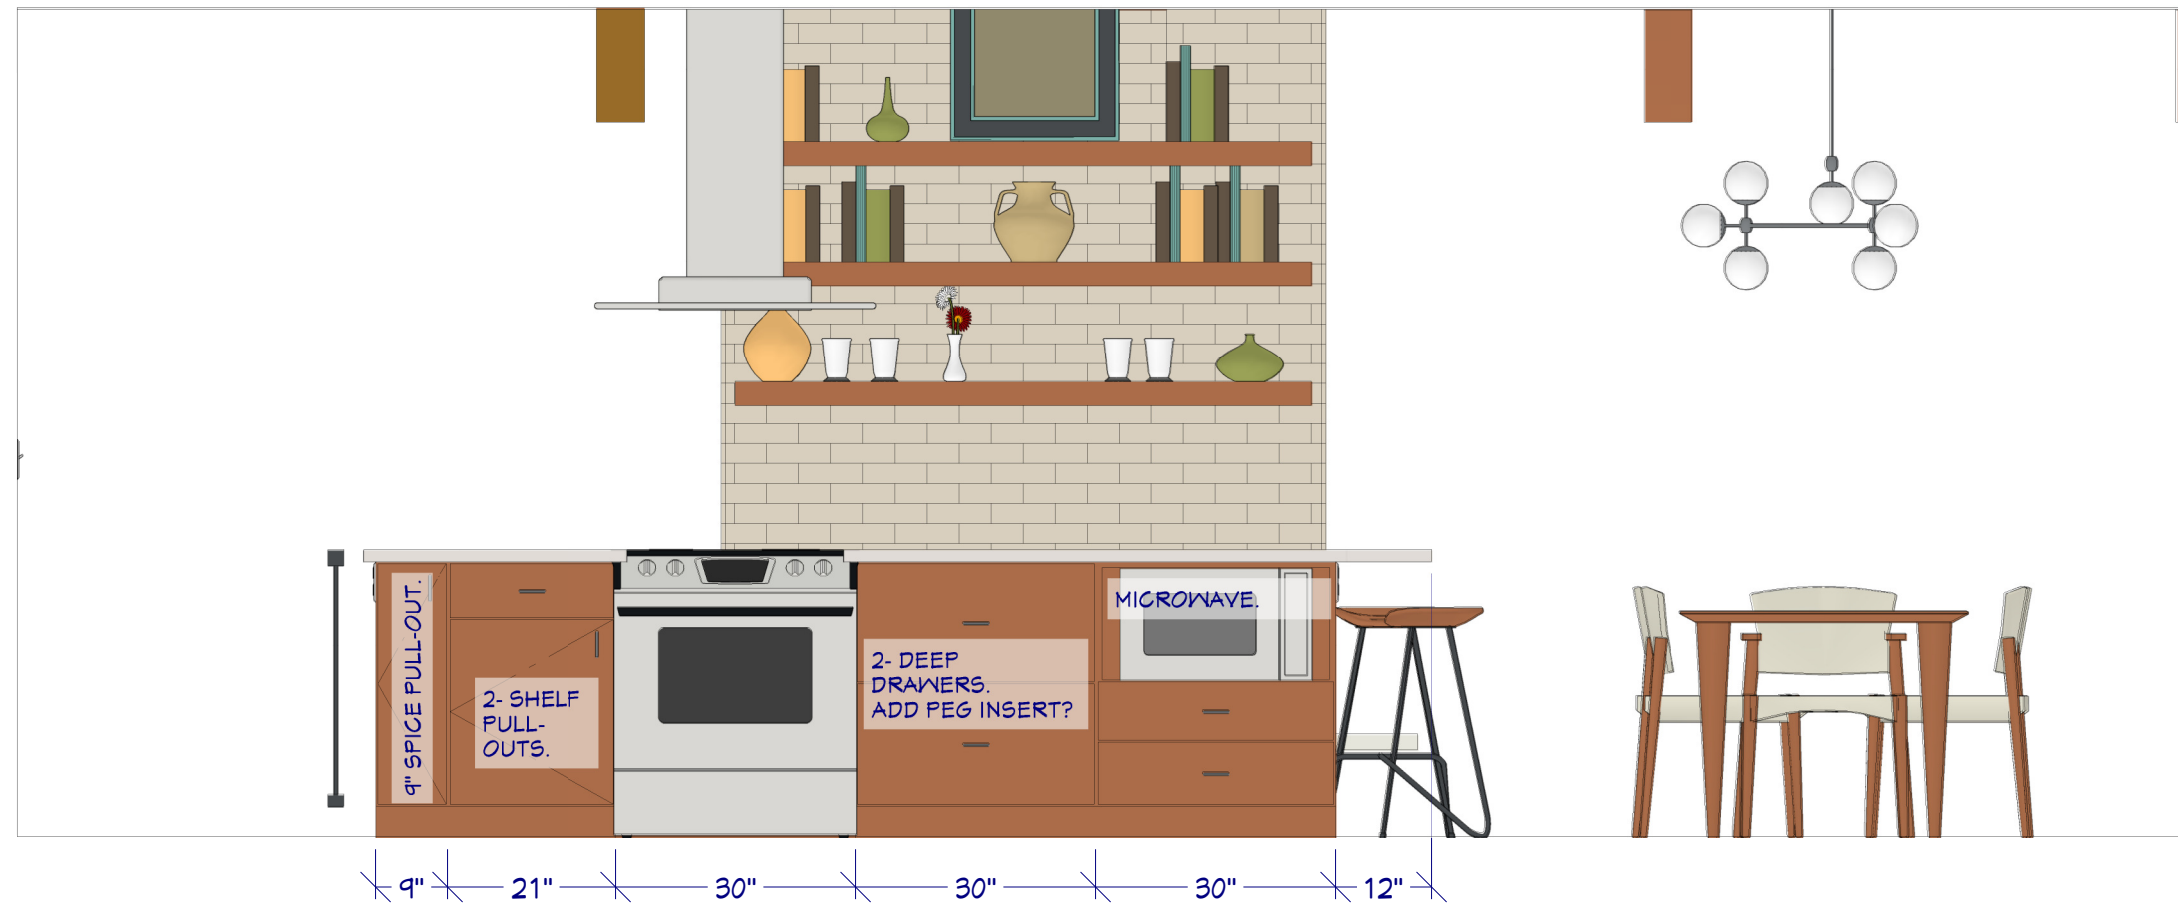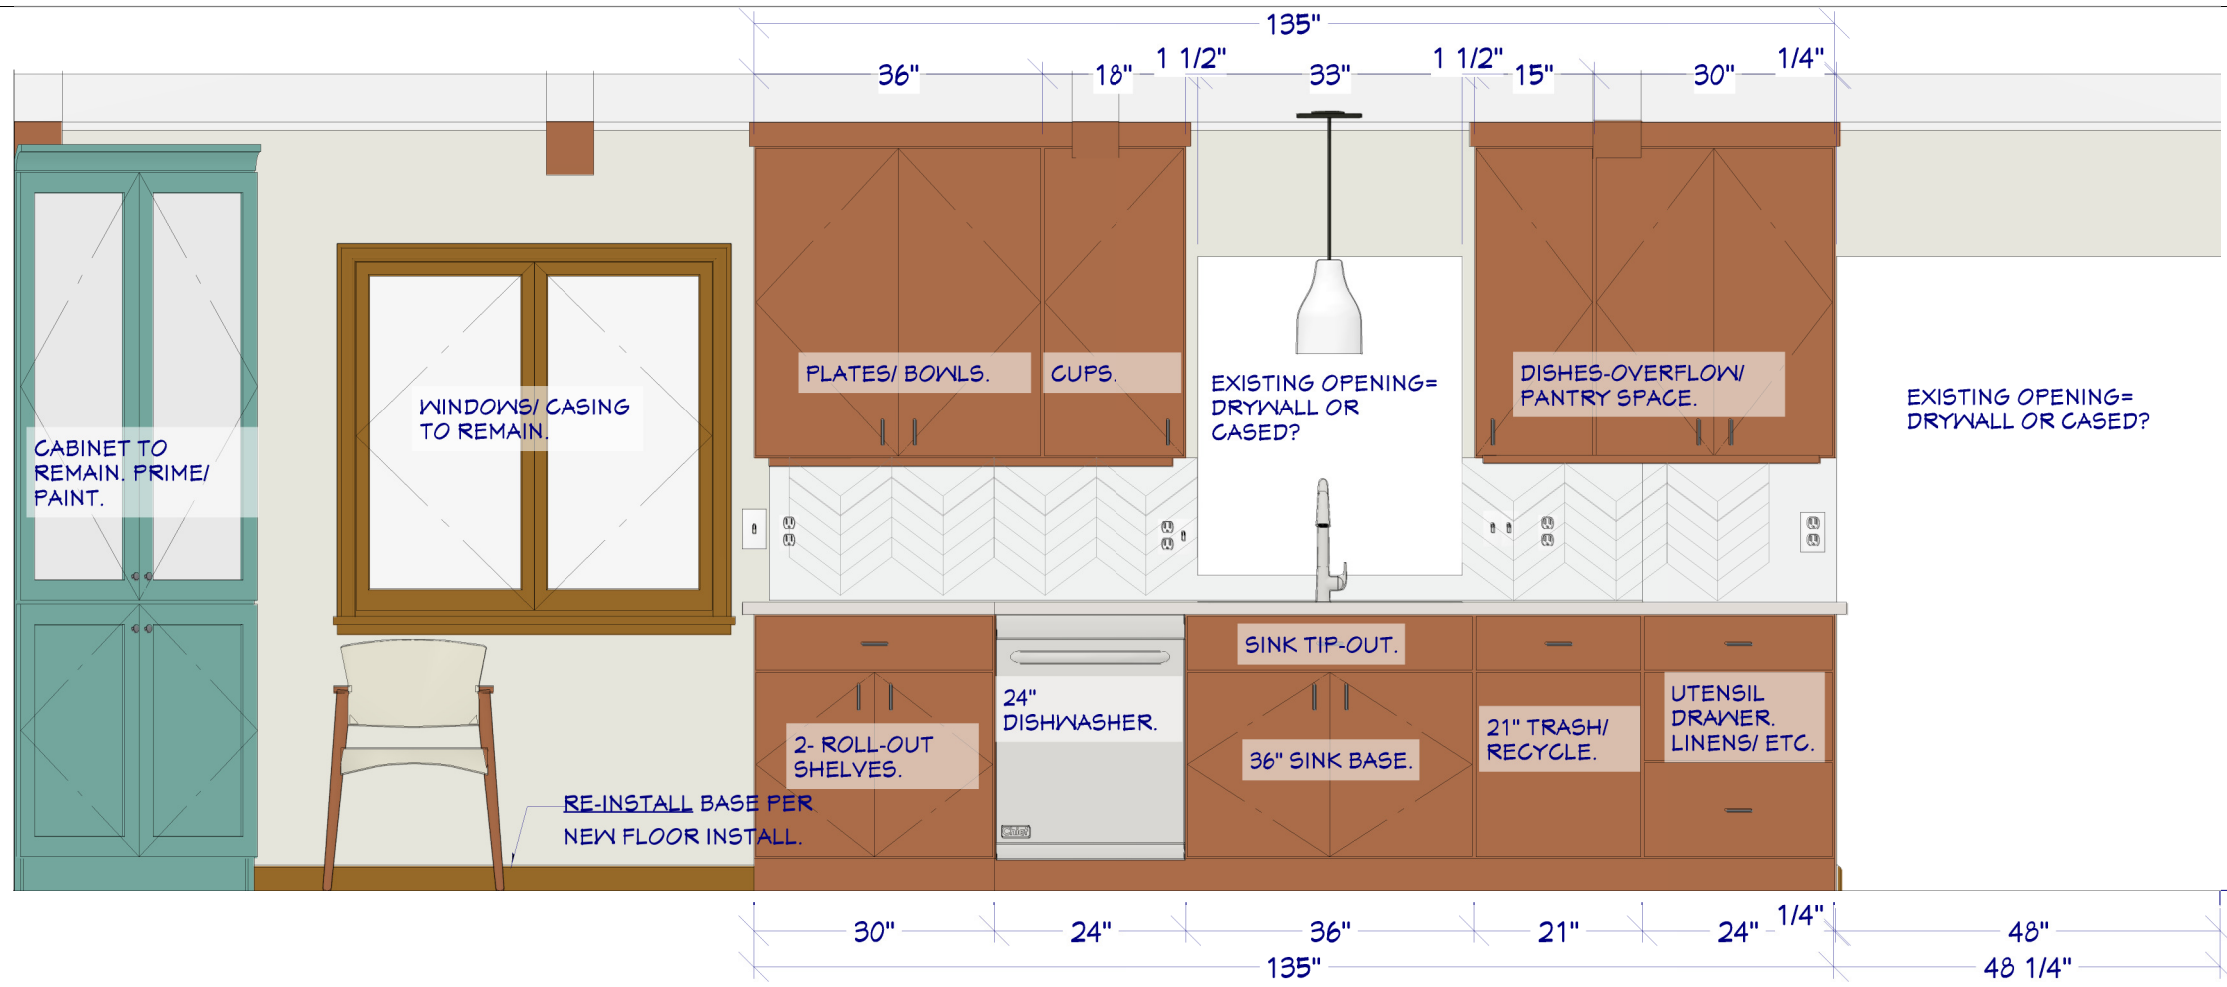

DATE: 11/9/2018

DRAWN BY: EMILY B.

REVISION DATES:

REV 1: --/--/--

Owner:

CONTRACTOR
LICENSE:


MN B005657

Phone: 612-784-8504



Fax: 612-784-8528

Castle
Building & Remodeling
2710 E 33rd St
Minneapolis, Minnesota 55406

PAGE 5

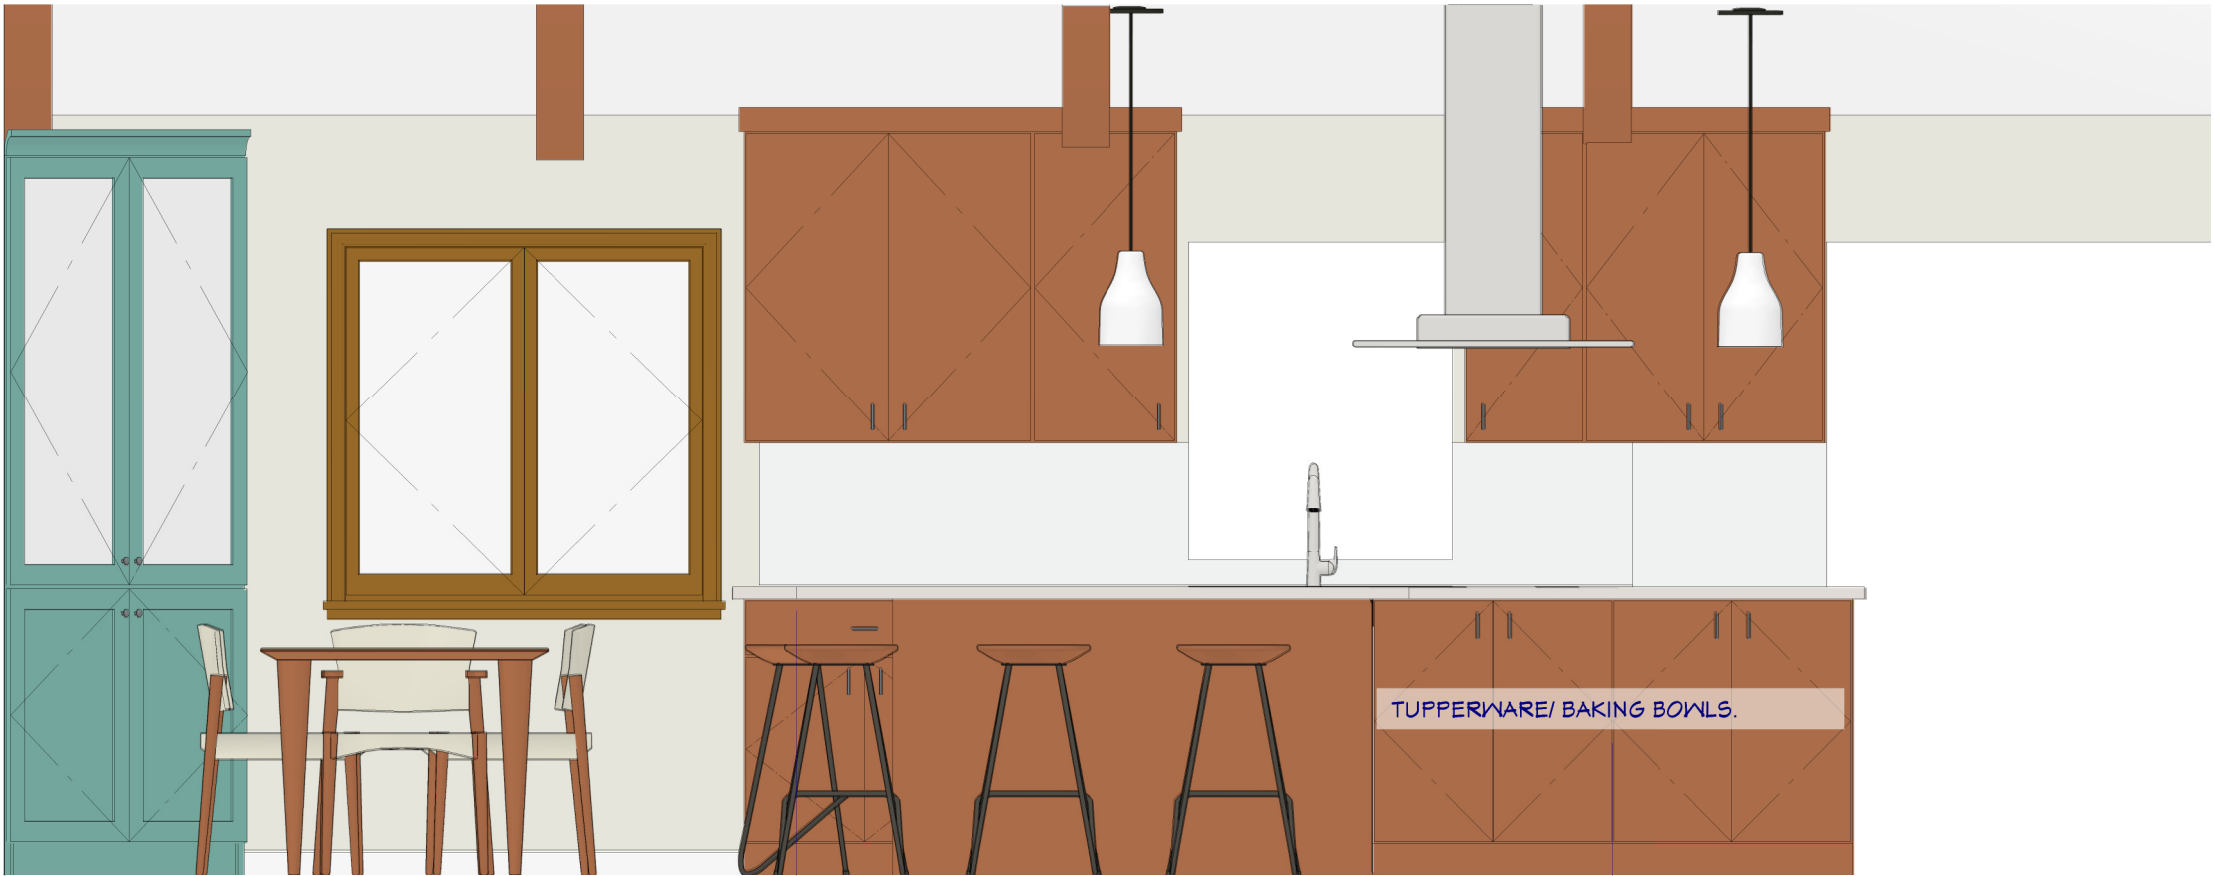

1' 5' 2'-6" 2'-6"

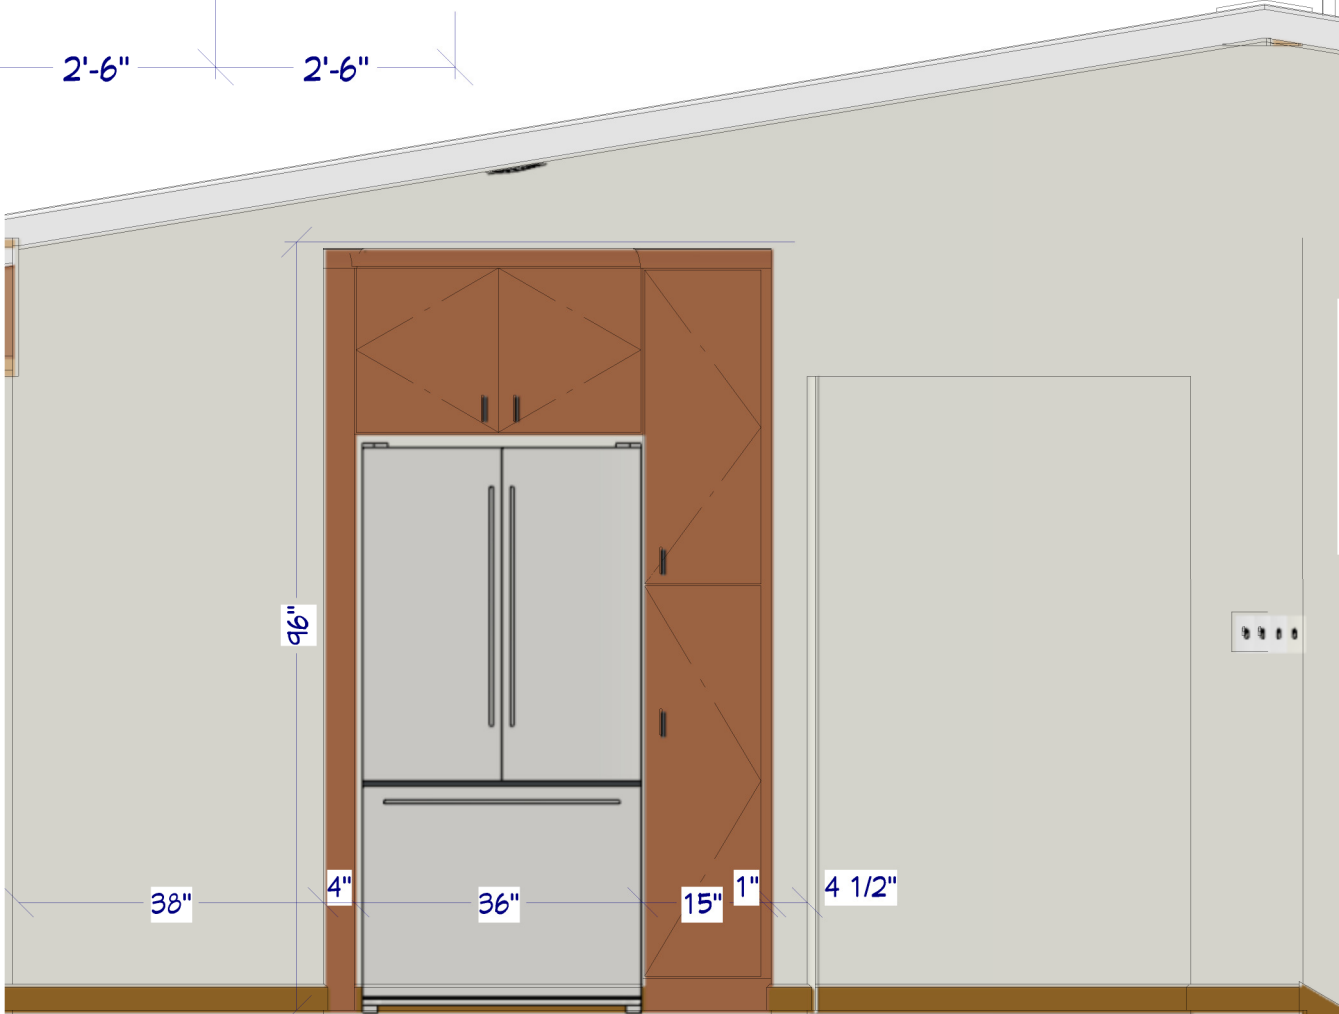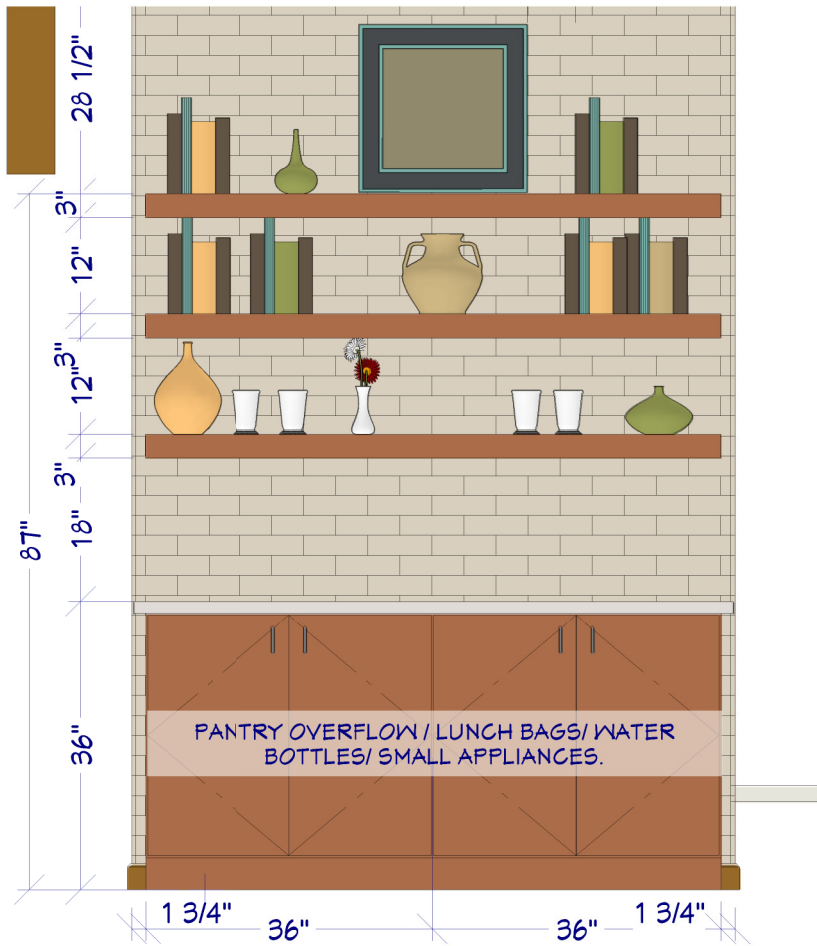

DATE: 11/9/2018

DRAWN BY: EMILY B.

REVISION DATES:

REV 1: --/--/--

Owner:

CONTRACTOR
LICENSE:

MN B005657

Phone: 612-784-8504

Fax: 612-784-8528

Castle
Building & Remodeling
2710 E 33rd St
Minneapolis, Minnesota 55406

PAGE 6



DATE: 11/9/2018

DRAWN BY: EMILY B.

REVISION DATES:

REV 1: --/--/--

Owner:

CONTRACTOR

LICENSE: MN B005657

Phone: 612-784-8504

Fax: 612-784-8528

Castle
Building & Remodeling
2710 E 33rd St
Minneapolis, Minnesota 55406

PAGE 7

